

1ST FLOOR LIGHTING

SCALE: 1/8" = 1 FOOT

LIGHTING FIXTURE SCHEDULE


TYPE	MANUFACTURER	CATALOG NUMBER	VOLTS	LAMPS	REMARKS
A	LUMARK	10W1G	120	100W A19	ELEVATOR PIT LIGHT
C1	SHAPER	404 36" CFL4/42 120 PB 24"	120	4-CF40TT	PENDANT BOWL
E1	SURE-LITES	CC5WHMRT	120	2-6V 9W	EMERGENCY LIGHT W/ REMOTE CAPACITY
F2	METALLUX	2GC AFA 232 A 125 120V EB81	120	2-F32T8/35K	2-TUBE ACRYLIC LENS TROFFER
F3	METALLUX	2EP3GAX-332 S361 120V EB82	120	3-F32T8/35K	3-TUBE PARABOLIC TROFFER
F3E	METALLUX	2EP3GAX-332 S361 120V EB82 FBP240	120	3-F32T8/35K	3-TUBE PARABOLIC TROFFER
F4	METALLUX	W232 A 120V EB81	120	2-F32T8/35K	SURFACE WRAP
F5E	METALLUX	BC232 120V EB81-FBP240M	120	2-F32T8/35K	4" WALL MOUNT W/ EMERGENCY BALLAST
F6	METALLUX	SN 232 120V EB81	120	2-F32T8/35K	4" STRIP
F7	METALLUX	BT SN 232 120V EB81	120	4-F32T8/35K	8" STRIP
F8	*	*	*	*	*
M1	RUIJD	SE5410-D	120	100W MH	12" UP/DOWN LIGHT
M2	RUIJD	SE4405-D	120	50W MH	8" DOWNLIGHT
R1	SURE-LITES	6X7MMHWH	6V DC	6V 7W	INCANDESCENT SEALED BEAM REMOTE HEAD
X1	SURE-LITES	LPX70RWH	120	LED	WHITE LED EXIT
X2	SURE-LITES	LPX70RWH	120	LED	WHITE LED EXIT - DOUBLE FACE
X3	SURE-LIGHTS	LPXH70RWH	120	LED	WHITE LED EXIT W/ REMOTE CAPACITY
X4	SURE-LIGHTS	LPX70RWHDH	120	LED	WHITE LED EXIT W/ EMERGENCY HEADS

NOTES:


T5 new or future?

OUTSIDE LIGHT CONTROL SCHEMATIC

NTS

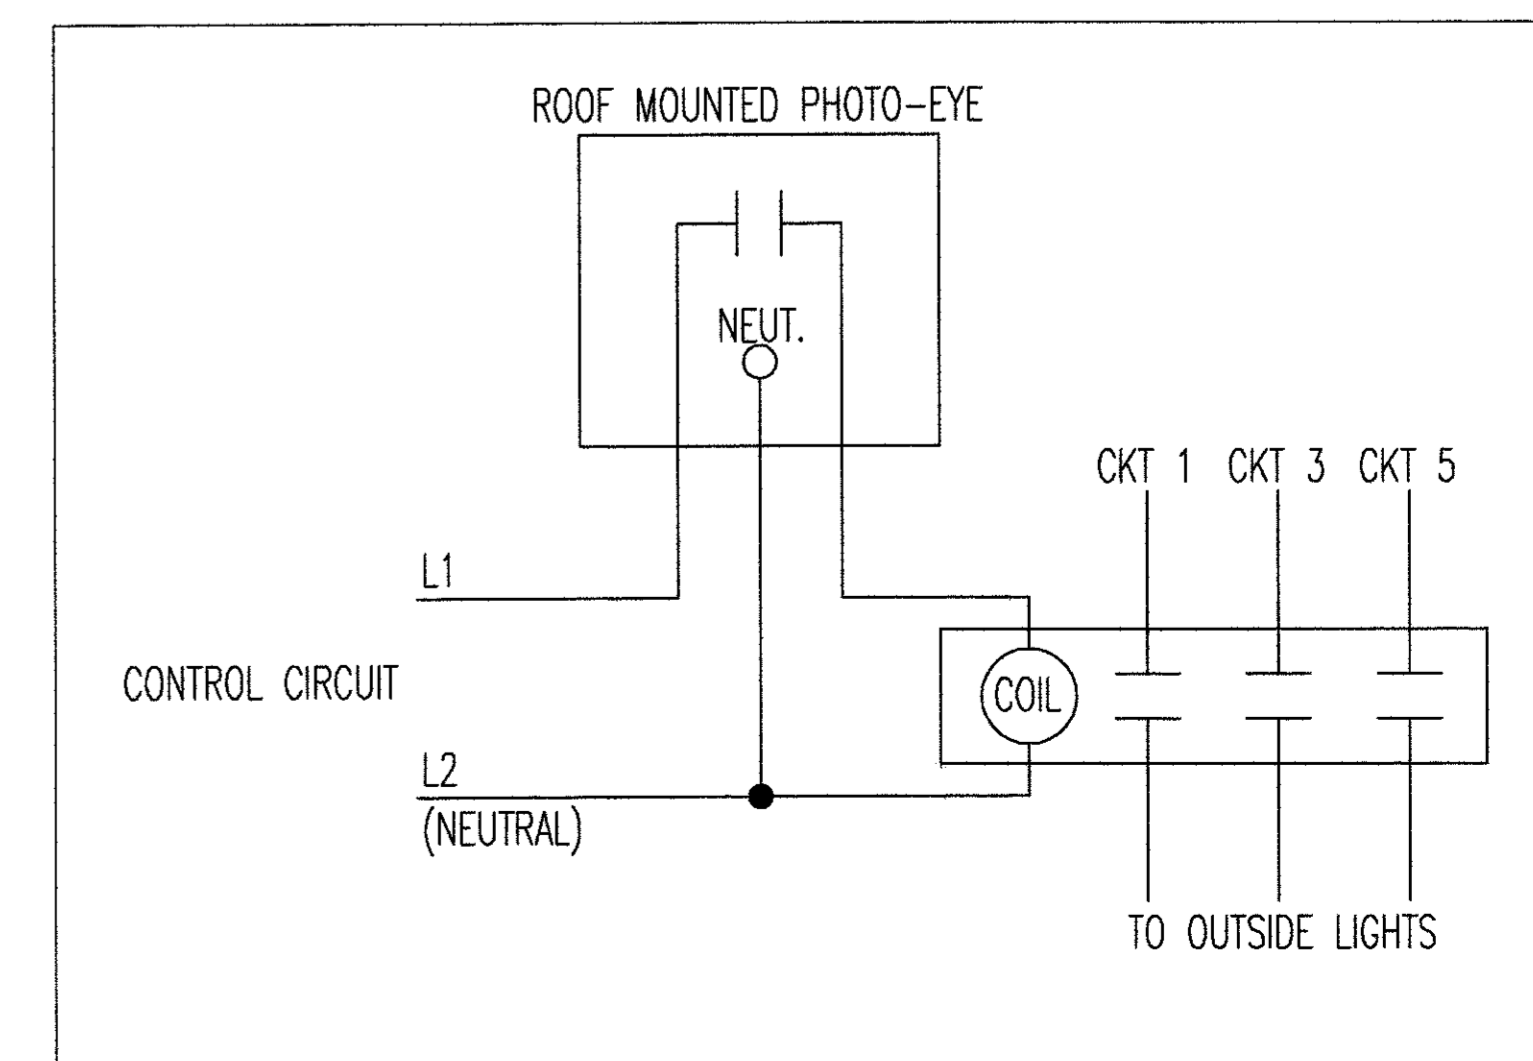

REVISION	DATE	DESCRIPTION

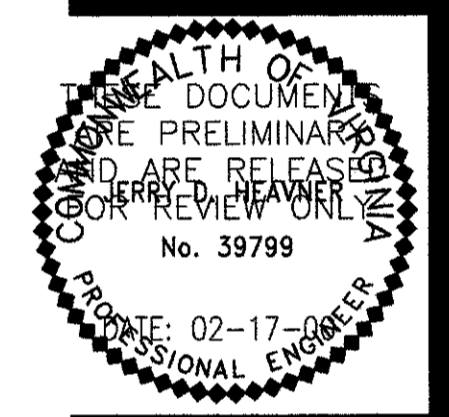

1ST FLOOR
 LIGHTING

ROCKINHAM CO. ADMIN.
 BUILDING

DRAWING FILE:
 DATE: 07/07
 SCALE: 1/8" = 1 FOOT UNLESS OTHERWISE NOTED
 DRAWN BY: BLS
 REVIEWED BY: