

1 2 3 4 5 6 7 8 9 10 11

A

B


C

D

E

F

G

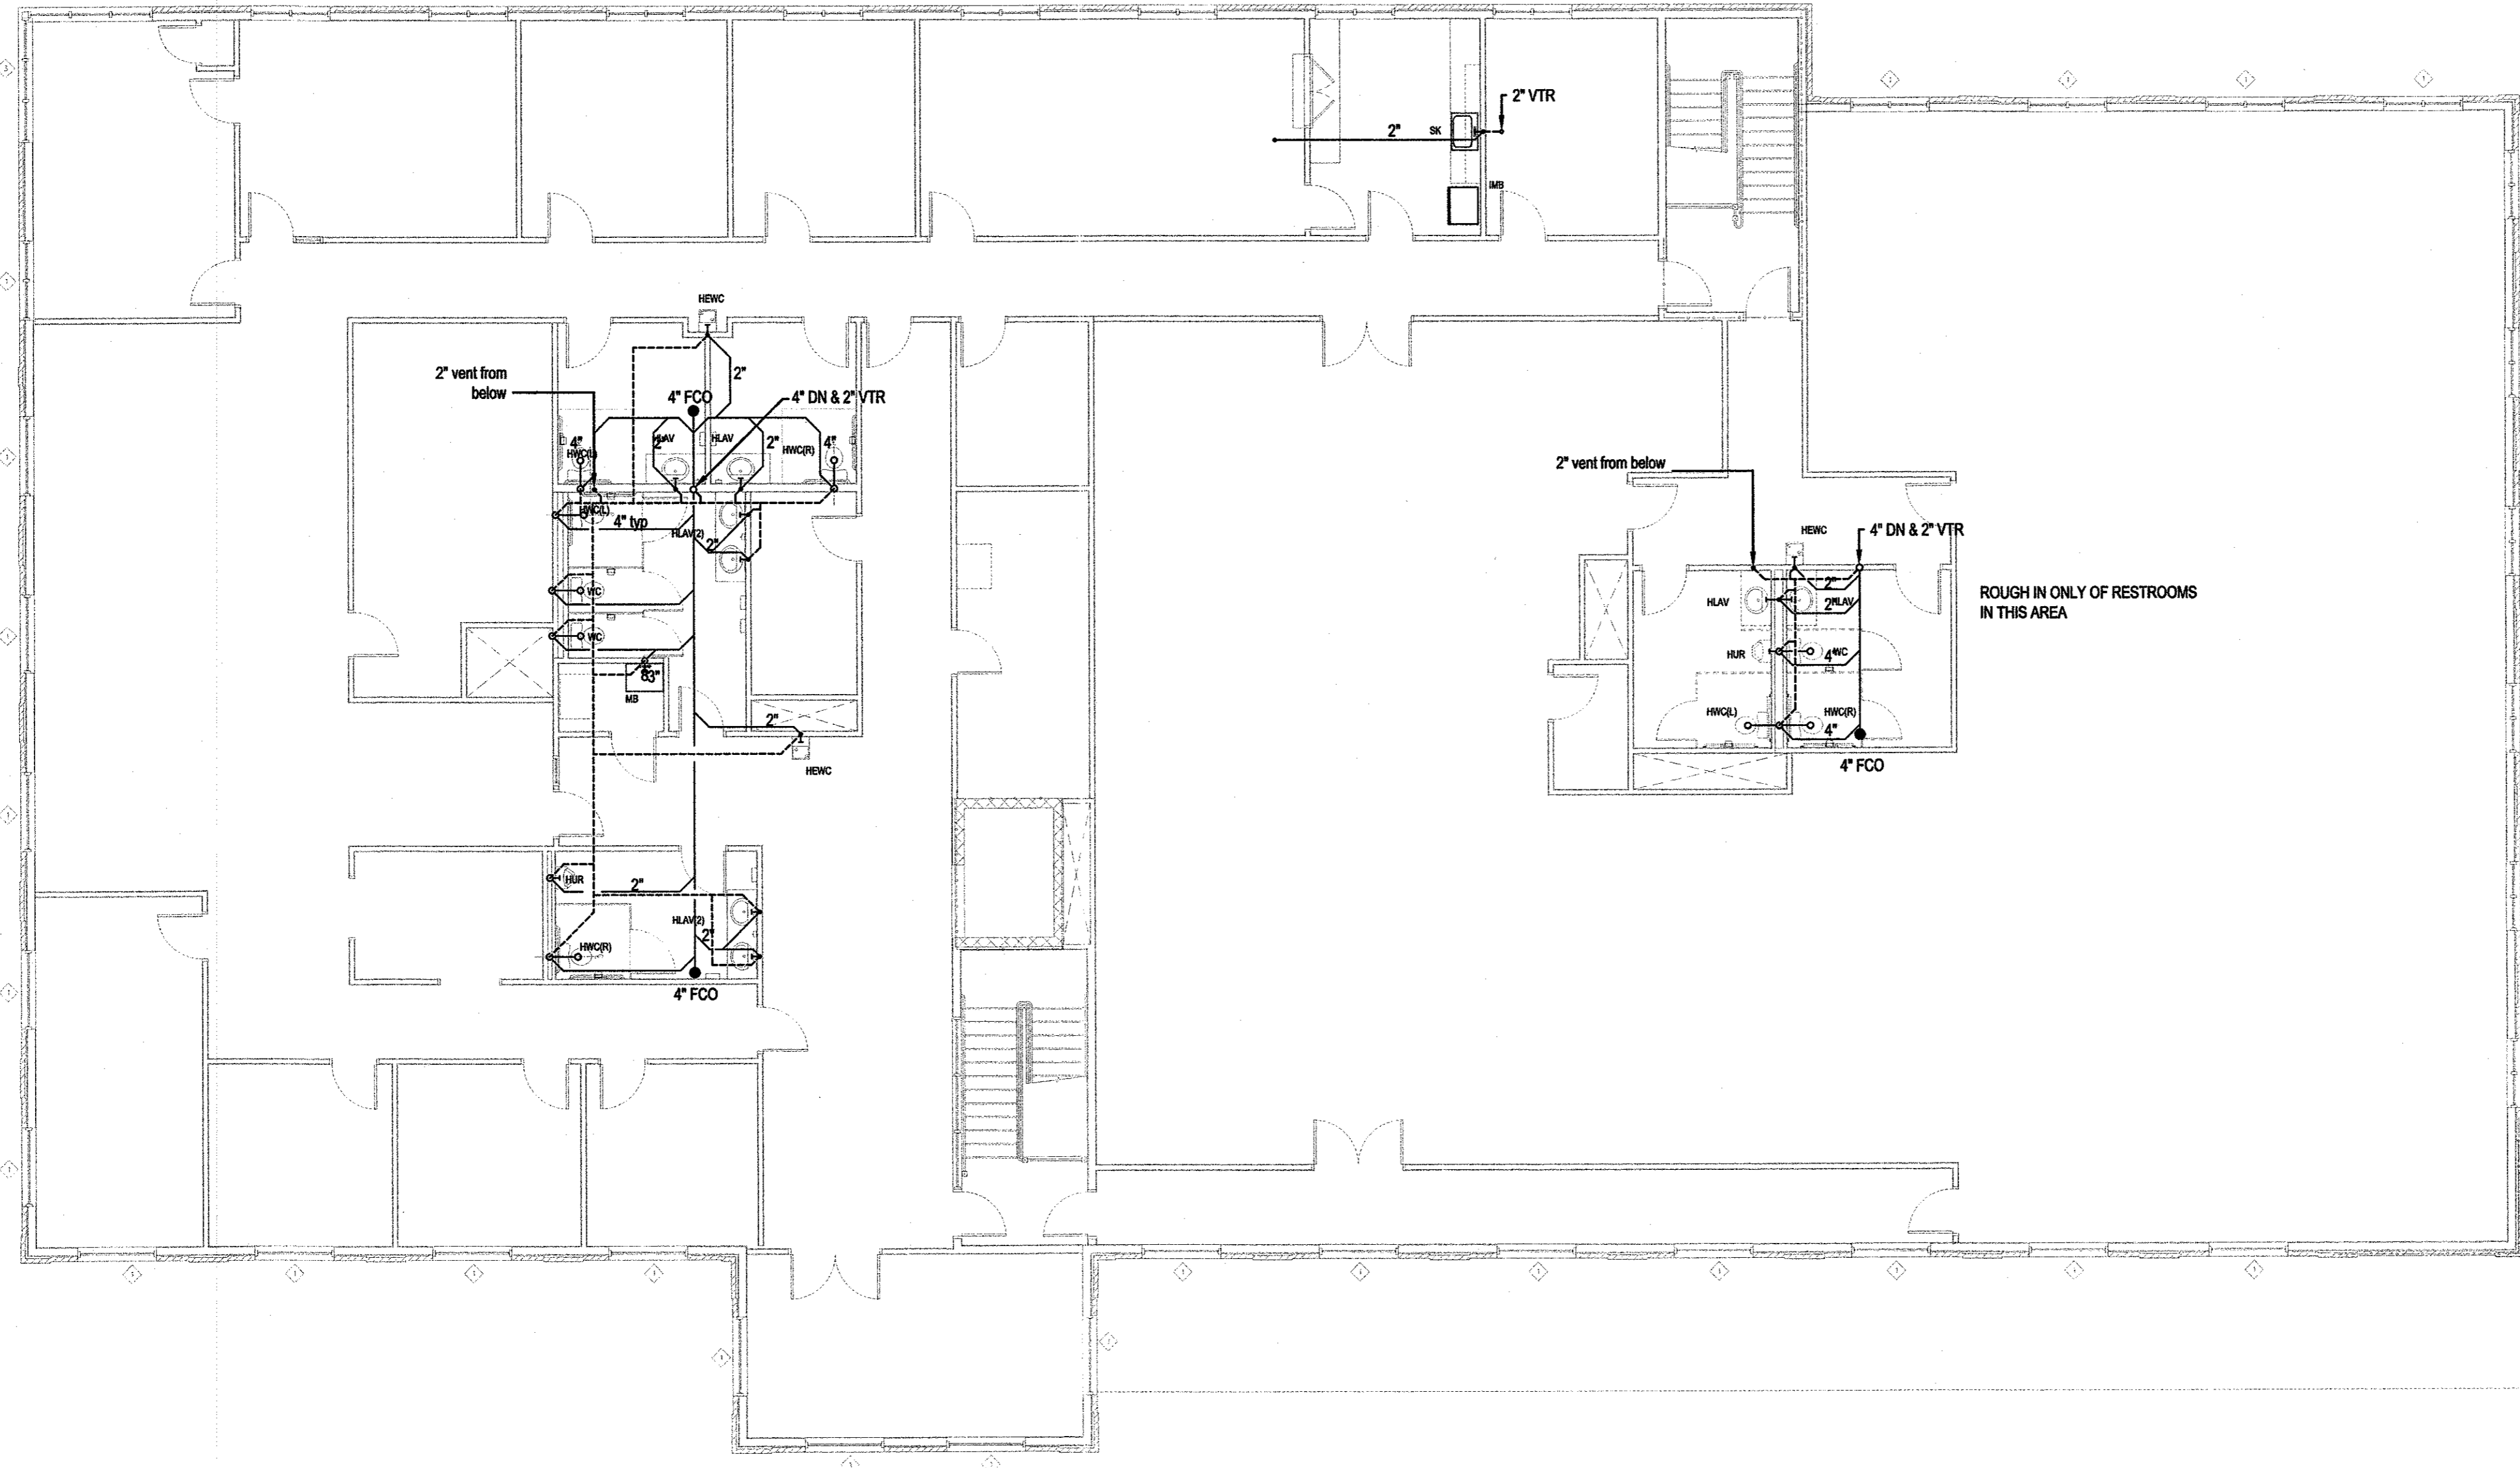


SECOND FLOOR PLAN

NOTE: ALL VENTING IS 2" IN SIZE.

THE DESIGNS AND PLANS SHOWN HERE WERE DEVELOPED FOR USE ON THIS PROJECT ONLY AND ARE THE PROPERTY OF BLAUCH BROTHERS, INC. THE DESIGN AND PLANS SHOWN SHALL NOT BE USED BY ANY PERSON, FIRM OR CORPORATION FOR ANY PURPOSE WHATSOEVER WITHOUT WRITTEN PERMISSION OF THIS OFFICE.

PROJECT	DATE
ROCKINGHAM CO. ADMINISTRATION 2008 ADDITION	11-12-07
DRAWING TITLE	
- SANITARY WASTE & VENT 2ND FLOOR	
REVISION -	DATE -
REVISION -	DATE -
REVISION -	DATE -

DRAWN BY
JB

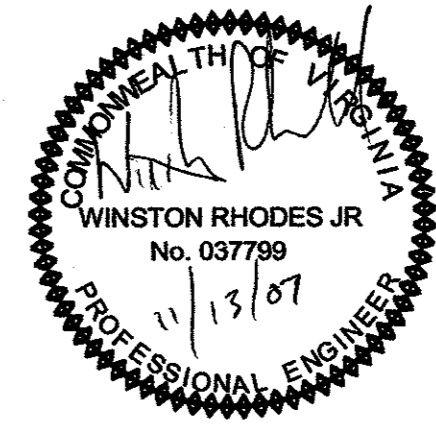

Blauch Brothers, Inc.
MECHANICAL CONTRACTORS
PH (540) 434 2589
FAX (540) 434 3690

P1.2

DRAWING NO.

1 2 3 4 5 6 7 8 9 10 11